


LEFT SIDE ELEVATION
SCALE: -----1/8" = 1'-0"

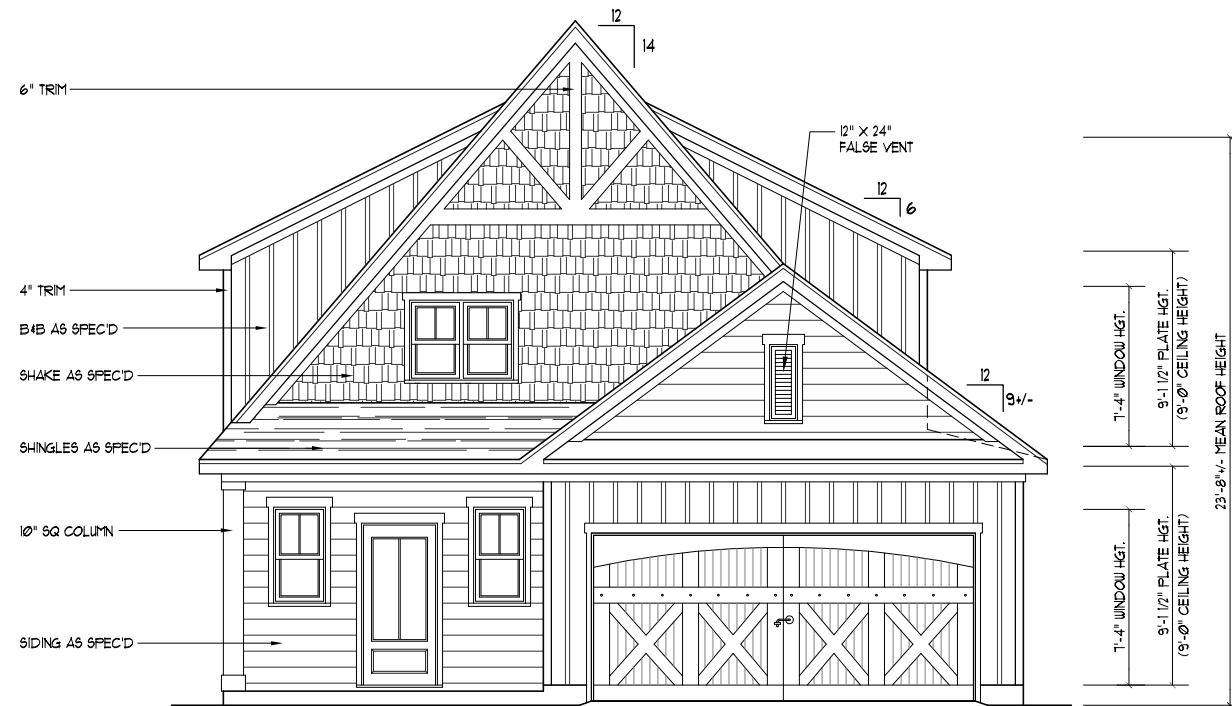

FRONT ELEVATION "C"
SCALE: -----1/4" = 1'-0"

THIS PLAN CONFORMS TO THE 2012 EDITION OF THE I.R.C. / NORTH CAROLINA RESIDENTIAL CODE.



REAR ELEVATION
SCALE: -----1/8" = 1'-0"



RIGHT SIDE ELEVATION
SCALE: -----1/8" = 1'-0"


DYNAMIC DESIGN GROUP, INC
David D Groun
(919) 601-1406
DynamicDesignGroup@gmail.com
www.DDGhomeplans.com

The drawings and specifications (plans) contained on these pages are the property of Dynamic Design Group and are offered to the named client or contractor for a conditional one time use. The conditional use is limited to the lot and subdivision specified herein, and only for said location. COPYRIGHT 2016
Contractor shall verify all conditions and dimensions prior to construction. Any error or omissions shall be reported to Dynamic Design Group for corrections or justification. Once construction has commenced, the contractor shall assume all responsibility. Dimensions govern over scale, code governs over dimensions.

PROJECT FOR: ALERCIA
LOCATION: MULTI
LOT: MULTI
SUBDIVISION: MULTI
COUNTY: MULTI

DYLAN
PLAN NAME
C-2033-34GR 9-16-16
PLAN I.D. DATE

A-1C
SHEET

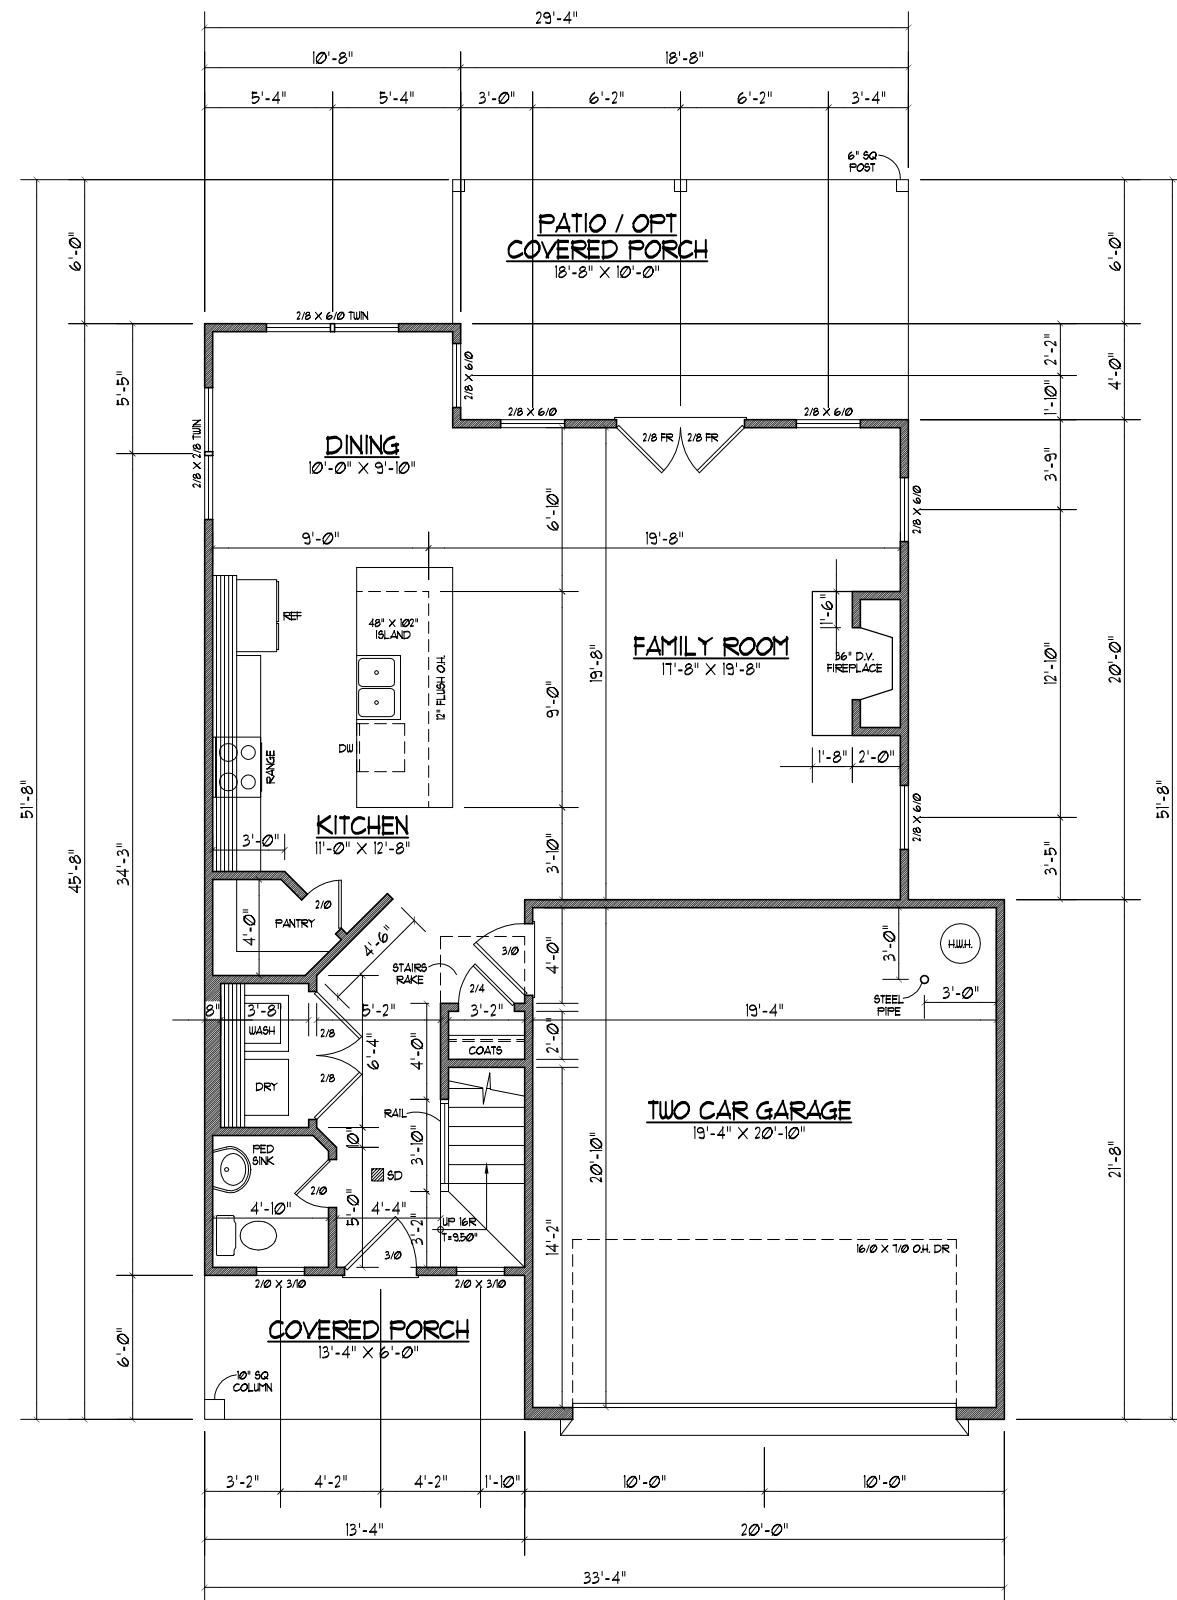


FIRST FLOOR PLAN

SCALE: -----1/8" = 1'-0"

849 HEATED SQ. FT.
 423 SQ. FT. GARAGE
 80 SQ. FT. COVERED PORCH
 189 SQ. FT. PATIO

- NOTES:
- 1) 9'-0" CLG. HGT. (9' - 1 1/2" FLT. HGT.) UNLESS OTHERWISE NOTED.
 - 2) ALL WALLS FIGURED AT 4" WIDTHS
 - 3) SET WINDOWS AT 7'-4" ASF. UNLESS OTHERWISE NOTED.
 - 4) DIMENSIONS ARE TO FRAMING UNLESS OTHERWISE NOTED.
 - 5) CONSULT WINDOW MANUFACTURER'S SPECS. FOR EGRESS REQUIREMENTS, PRESSURE RATINGS, & ROUGH OPENINGS.
 - 6) ELECTRICAL LAYOUT BY BUILDER / SD = SMOKE DETECTOR

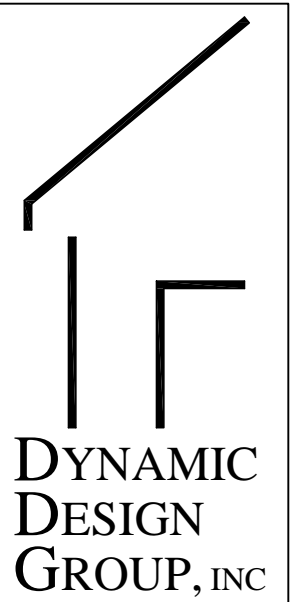

DYNAMIC DESIGN GROUP, INC

David D Grould
 (919) 601-1406
 DynamicDesignGroup@gmail.com
 www.DDGhomeplans.com




The drawings and specifications (plans) contained on these pages are the property of Dynamic Design Group and are offered to the named client or contractor for a conditional one time use. The conditional use is limited to the lot and subdivision specified herein, and only for said location. COPYRIGHT 2016

Contractor shall verify all conditions and dimensions prior to construction. Any error or omissions shall be reported to Dynamic Design Group for corrections or justification. Once construction has commenced, the contractor shall assume all responsibility. Dimensions govern over scale, code governs over dimensions.

PROJECT FOR: ALERCIA
 LOCATION: MULTI
 LOT: MULTI
 SUBDIVISION: MULTI
 COUNTY: MULTI

DYLAN
 PLAN NAME
C-2033-34GR 9-16-16
 PLAN I.D. DATE

A-2
 SHEET

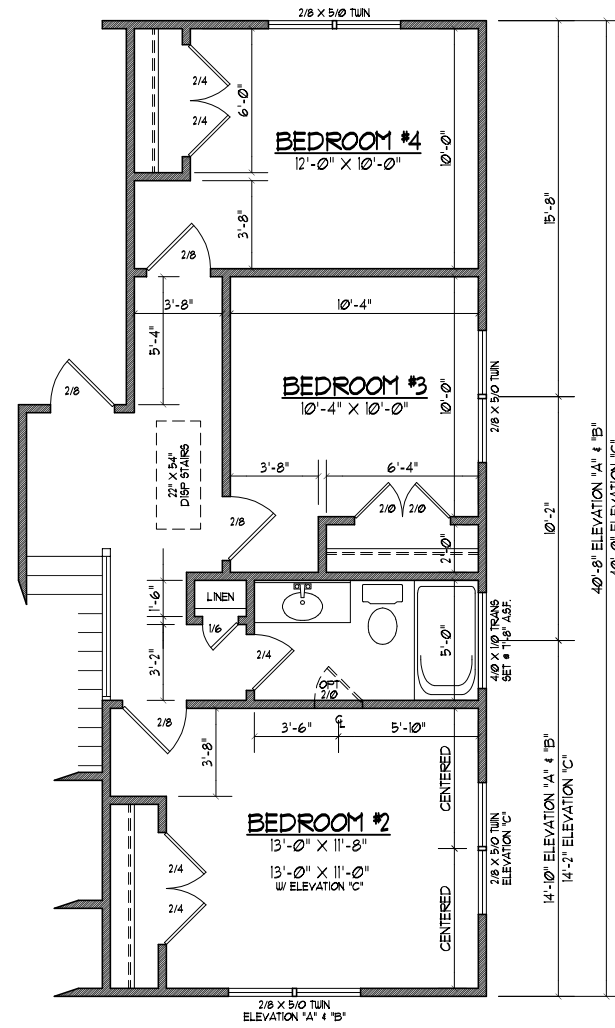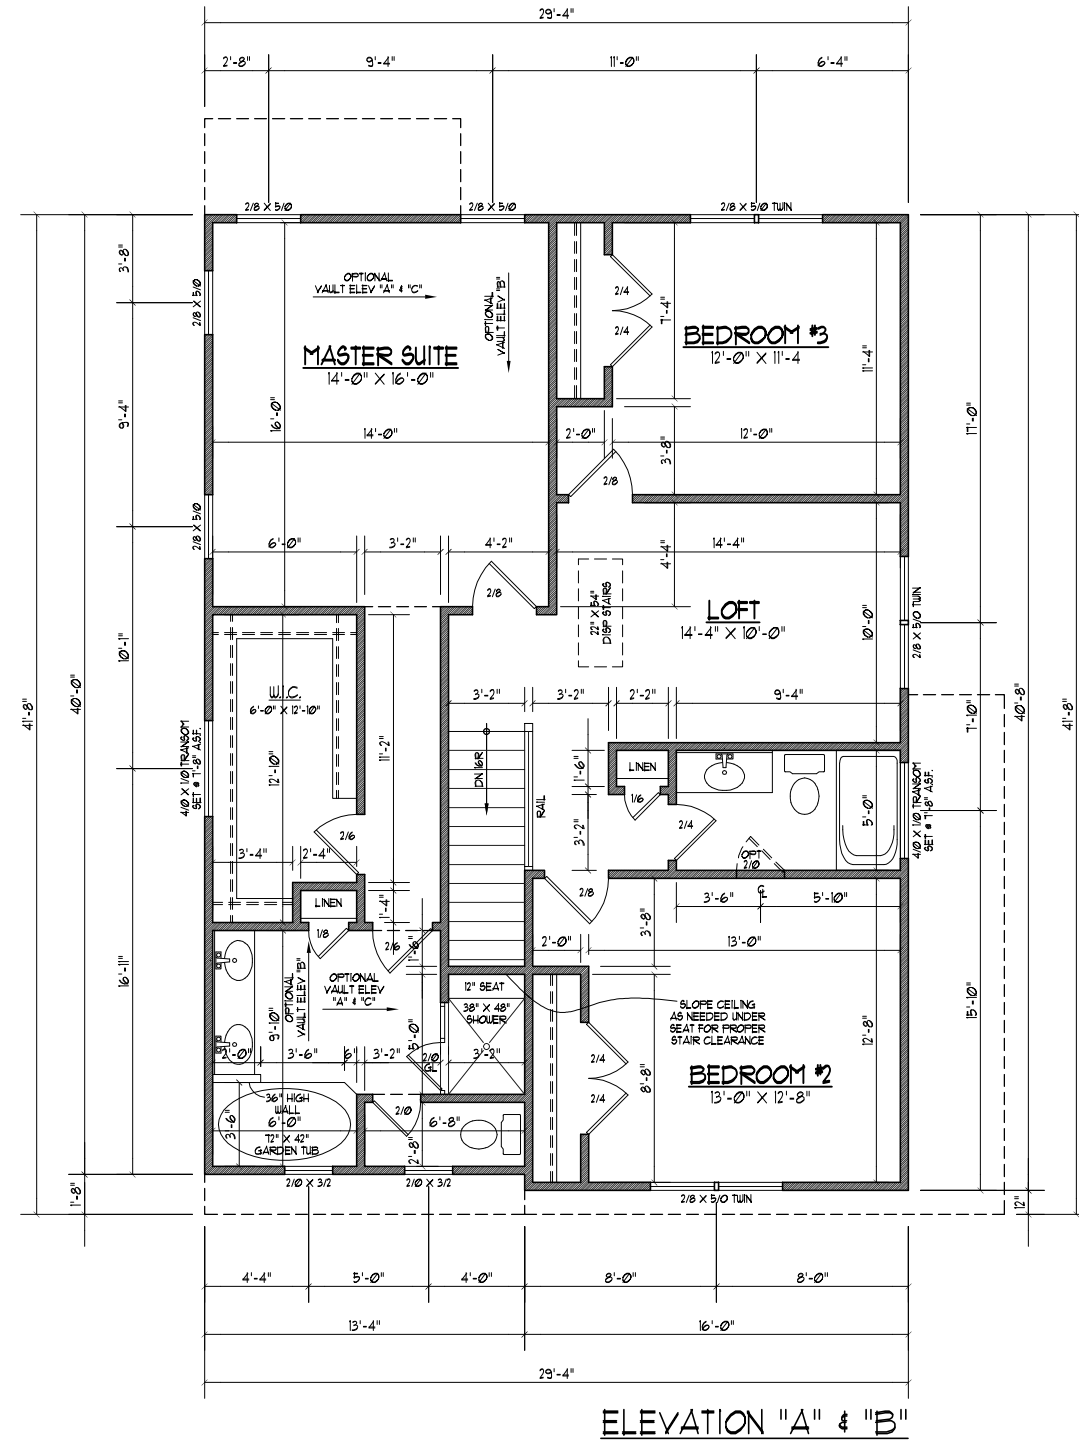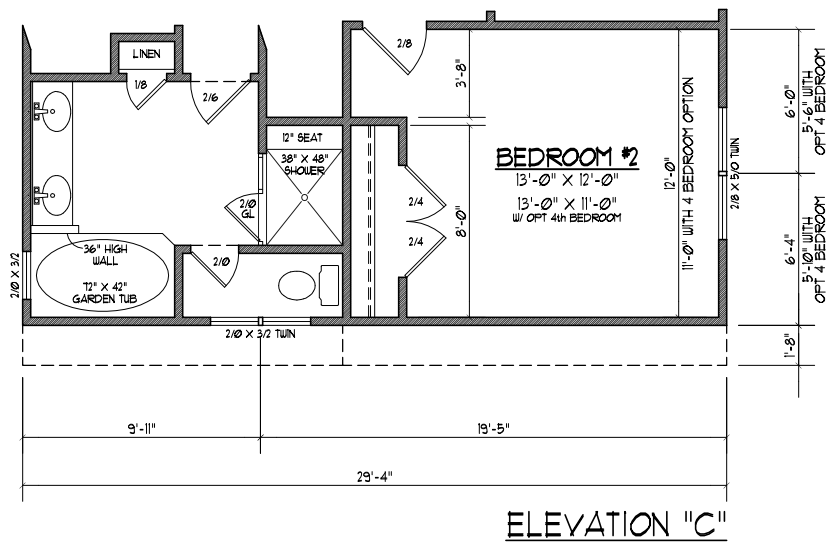

SECOND FLOOR PLAN
SCALE: -----1/8" = 1'-0"

184 HEATED SQ. FT.

- NOTES:**
- 1) 9'-0" CLG. HGT. (9' - 1 1/2" PLT. HGT.)
 - 2) ALL WALLS FIGURED AT 4" WIDTHS UNLESS OTHERWISE NOTED.
 - 3) SET WINDOWS AT T-4" A.S.F. UNLESS OTHERWISE NOTED.
 - 4) DIMENSIONS ARE TO FRAMING UNLESS OTHERWISE NOTED.
 - 5) CONSULT WINDOW MANUFACTURER'S SPECS. FOR EGRESS REQUIREMENTS, PRESSURE RATINGS, & ROUGH OPENING.
 - 6) ELECTRICAL LAYOUT BY BUILDER / SD - SMOKE DETECTOR

DYNAMIC DESIGN GROUP, INC

David D Grond
(919) 601-1406
DynamicDesignGroup@gmail.com
www.DDHomeplans.com

The drawings and specifications (plans) contained on these pages are the property of Dynamic Design Group and are offered to the named client or contractor for a conditional one time use. The conditional use is limited to the lot and subdivision specified herein, and only for said location. COPYRIGHT 2016
Contractor shall verify all conditions and dimensions prior to construction. Any error or omissions shall be reported to Dynamic Design Group for corrections or justification. Once construction has commenced, the contractor shall assume all responsibility. Dimensions govern over scale, code governs over dimensions.

PROJECT FOR: ALERCIA
LOCATION: MULTI
LOT: MULTI
SUBDIVISION: MULTI
COUNTY: MULTI

DYLAN
PLAN NAME

C-2033-34GR 9-16-16
PLAN I.D. DATE

A-3
SHEET